



KERR SCOTT BUILDING
SECOND FLOOR PLAN
NOT TO SCALE

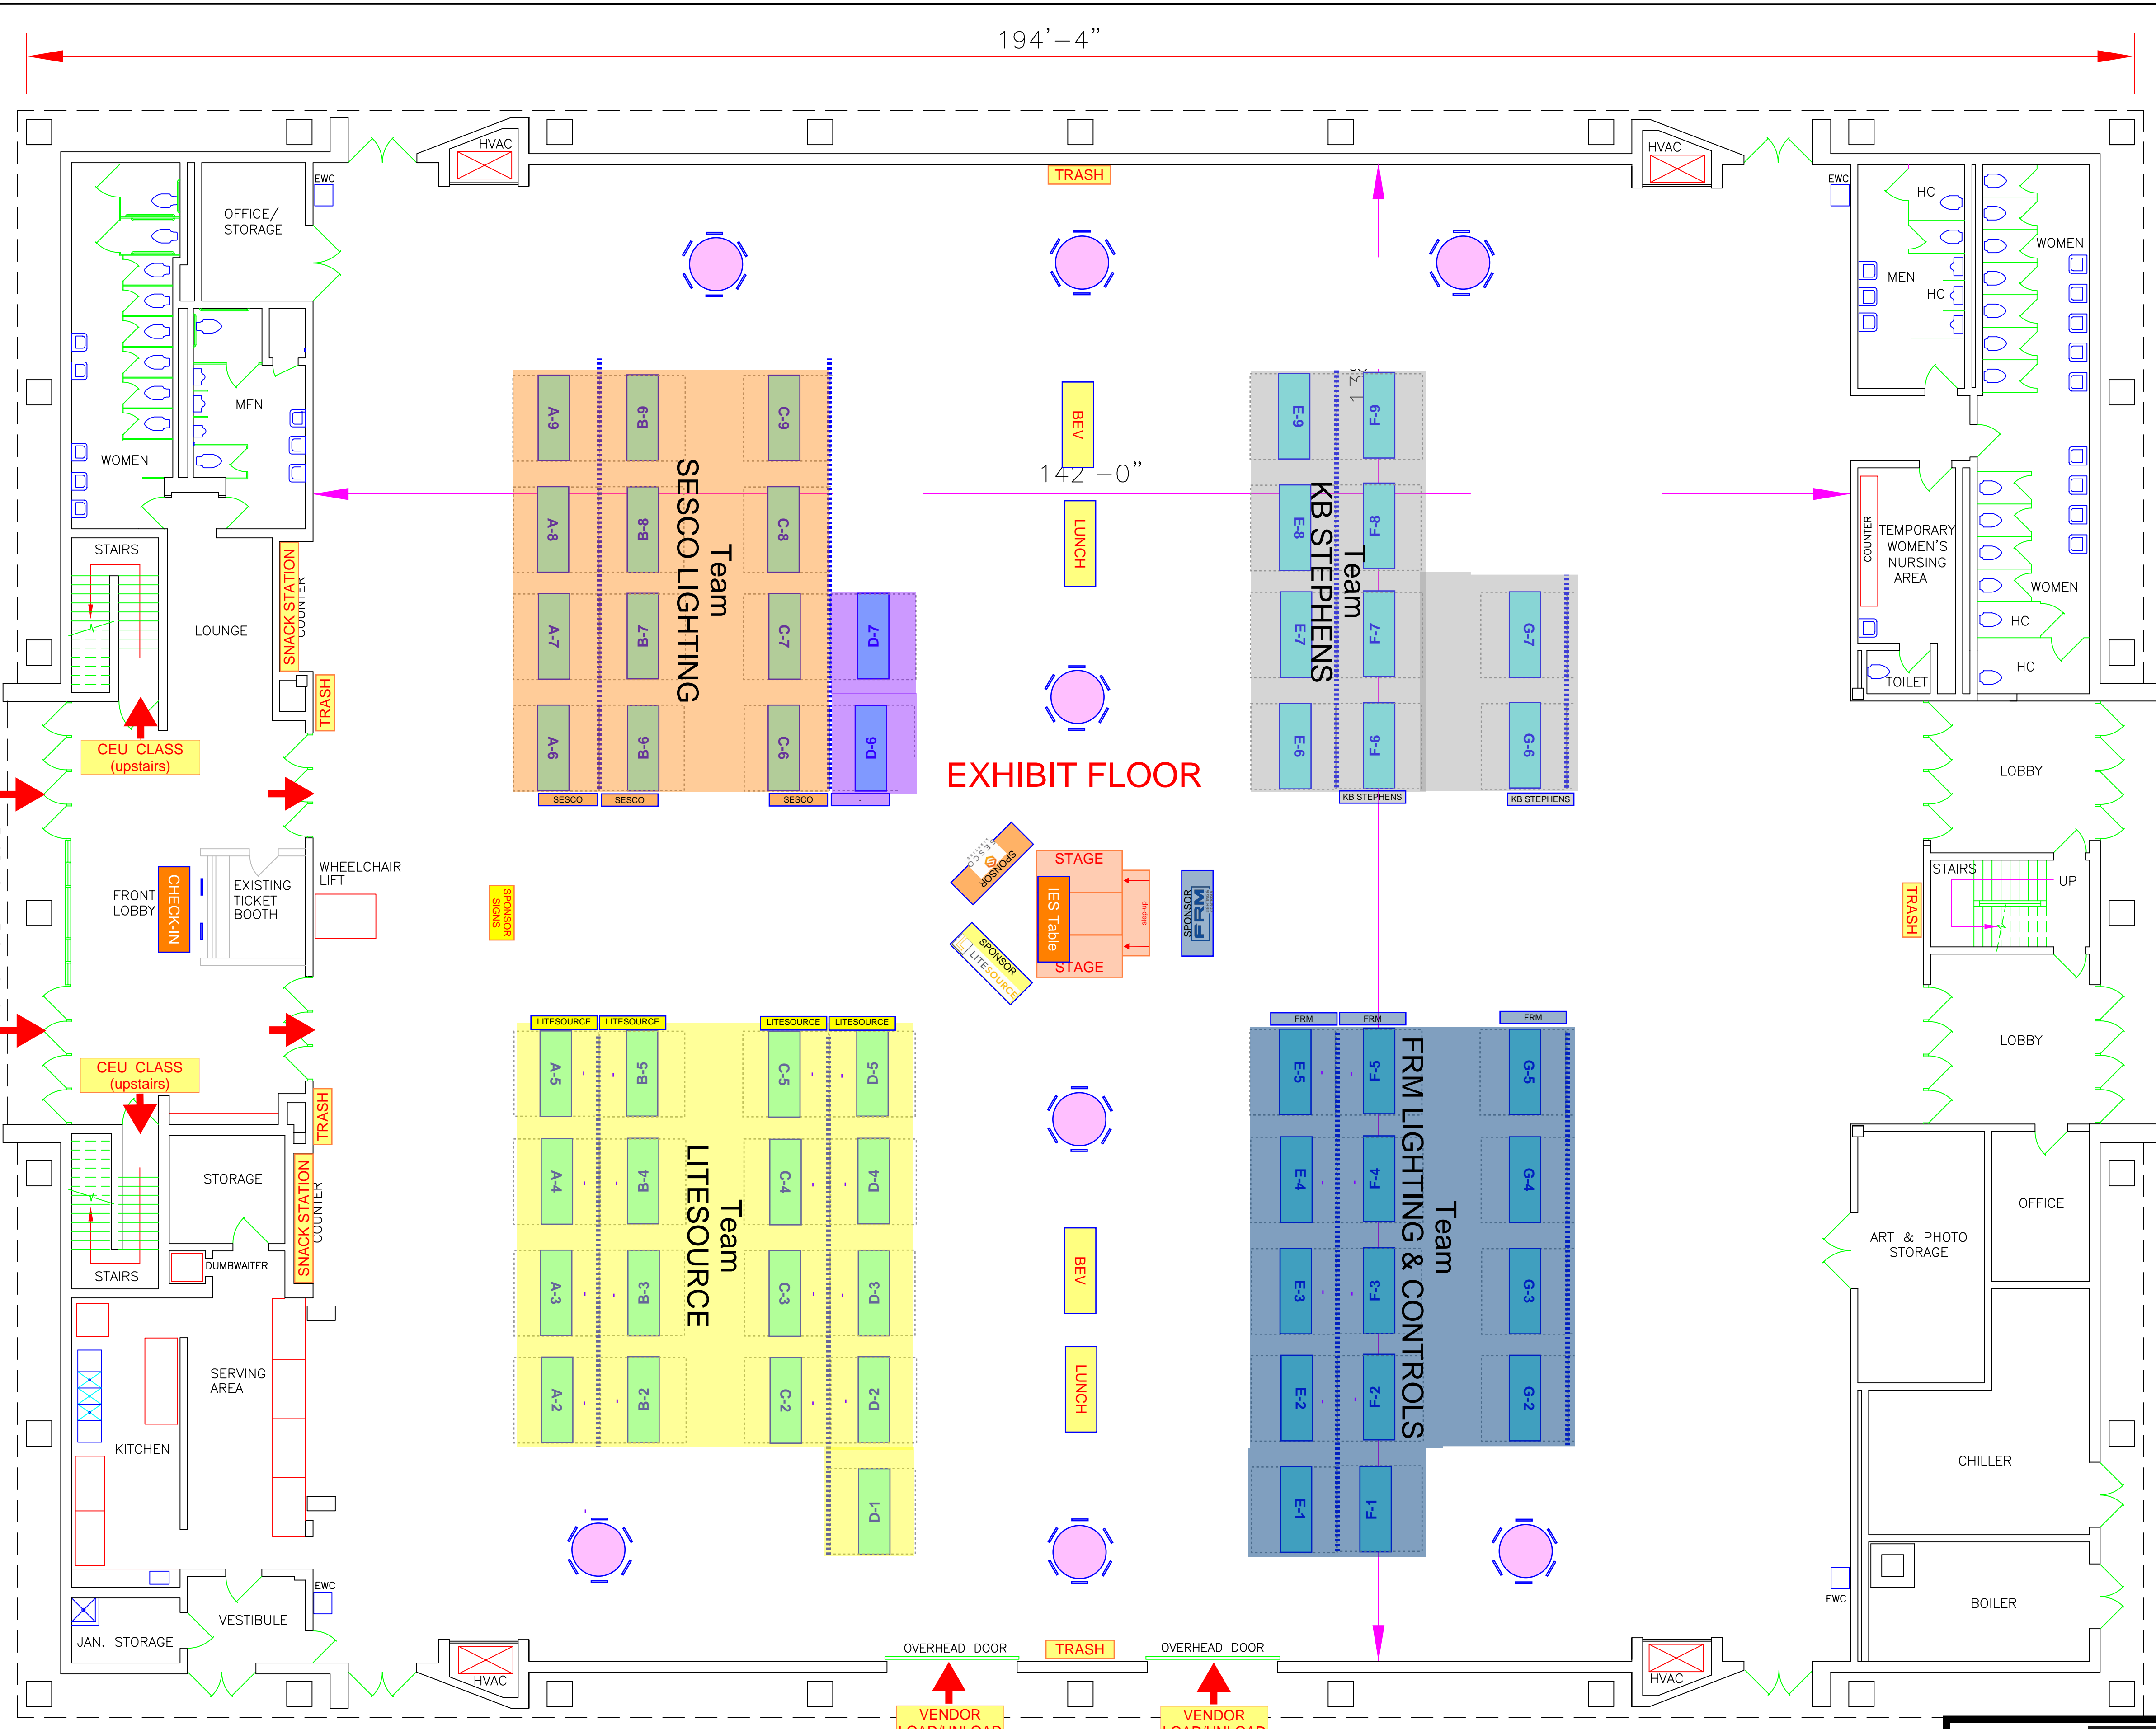

LINE OF ROOF OVERHANG ABOVE

TO BLUE RIDGE ROAD

KERR SCOTT BUILDING
FIRST FLOOR PLAN
1/8" = 1'-0"

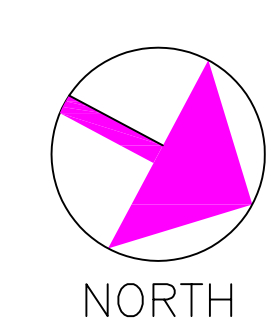

- EXHIBITORS**
- Team: SESCO Lighting**
 Bock Lighting
 DMF Lighting
 ETC, Inc.
 H.E. Williams, Inc.
 Insight
 Kuzco Lighting
 Landscape Forms
 Legrand Wattstopper
 Leviton Lighting
 SESCO Lighting
 TMS Lighting Inc
 Valaria Systems
- Team: Unaffiliated**
 IALD (sponsor: Lux Illuminaire)
 WILD (sponsor: Landscape Forms)
 Invictus Lighting, LLC
- Team: KB Stephens**
 ALW
 ANP Lighting
 BEGA North America
 KB Stephens
 Kirlin Lighting
 Lumenpulse
 Vode Lighting
 Wisconsin Lighting Lab
 New Start Lighting
 Acuity Brands

- EXHIBITORS**
- Team: LiteSource**
 Alliance Composites
 Coronet
 Elite Lighting
 Green Creative
 ILP
 Justice Design Group
 Kreon
 Leviton Certolux | Visioneering
 Leviton Controls
 LUX Illuminaire
 Myers Emergency Power Systems
 NLS Lighting
 Nova Flex
 Orion
 Sensorworx
 Times Square Lighting
 vHealth Lighting | Vantage
- Team: FRM Lighting & Controls**
 Current
 Current
 Current Lighting
 Current Lighting
 FRM
 FRM Lighting & Controls
 LED Inspirations
 Lightalams / ABB
 Lutron
 LUTRON ELECTRONICS CO., INC.
 MODA Light
 PMC Lighting
 SAGE Brands
 Vista Professional Outdoor Lighting

IES Raleigh
Section

VENDOR TRADESHOW

WED | 18 MAR 2026 | 11am-5pm

NC State Fairgrounds | Kerr Scott Building
4285 Trinity Road, Raleigh, NC 27607